
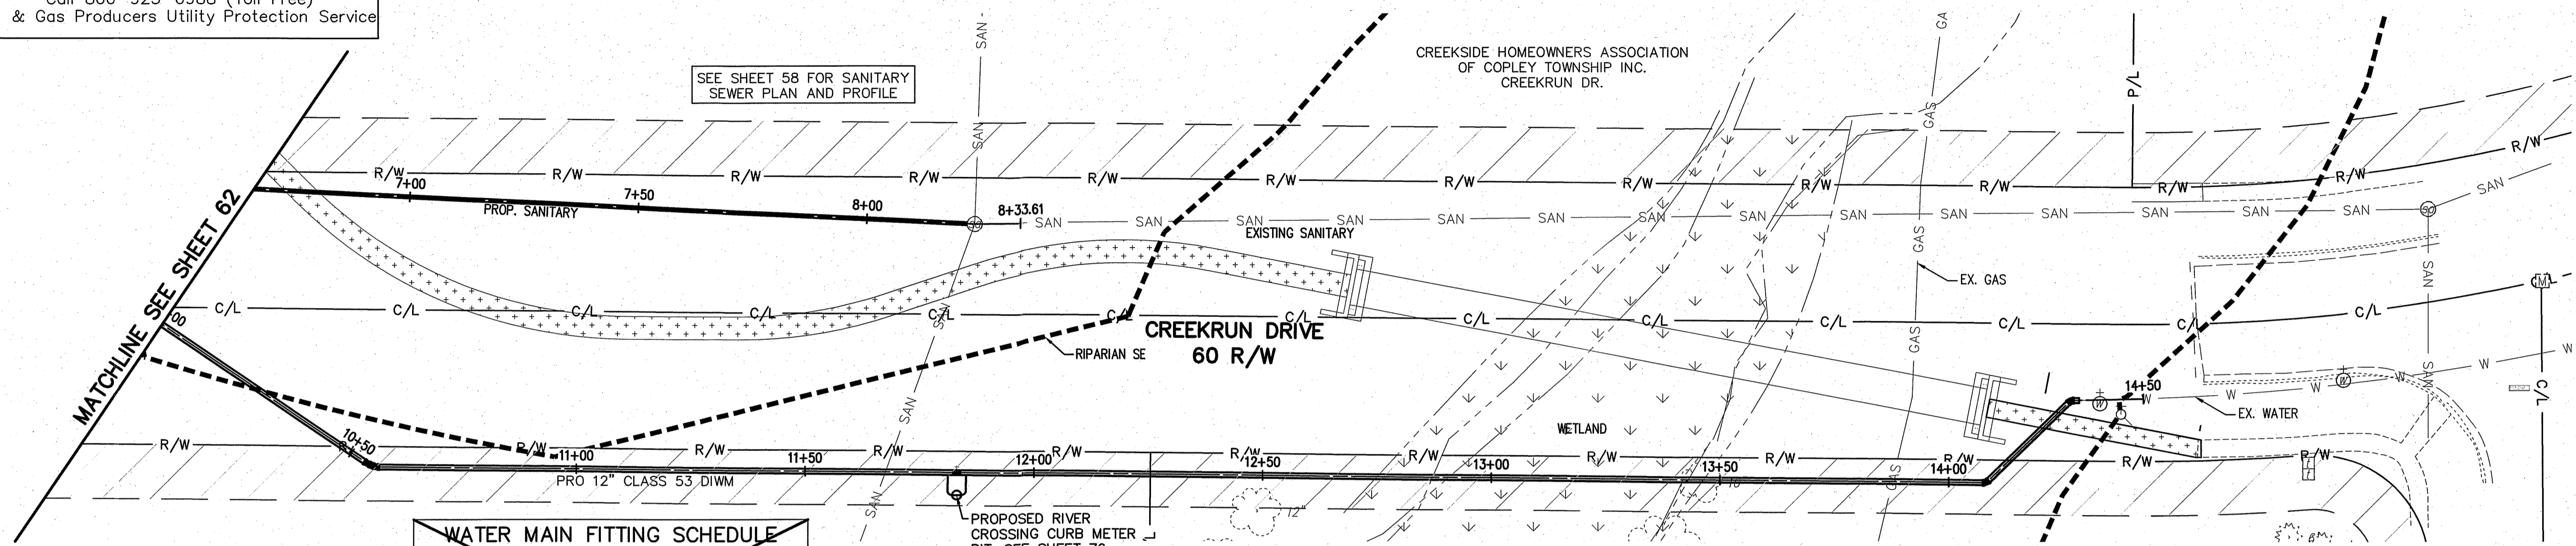


Underground Utilities

2 Working Days Before You Dig
Call 800-362-2764 (Toll Free)
Ohio Utilities Protection Service

Non-members Must Be Called Directly
Call 800-925-0988 (Toll Free)
Oil & Gas Producers Utility Protection Service

STORM SEWER
REFER TO GENERAL NOTES SHEET 5 FOR GENERAL NOTES.
ALL RCP PIPE SHALL BE CLASS 4 PER ODOT 706.02
ALL HDPE PIPE SHALL BE SMOOTH LINED PER ODOT 707.33
ALL PVC PIPE SHALL BE SDR 35 PER ODOT 707.45

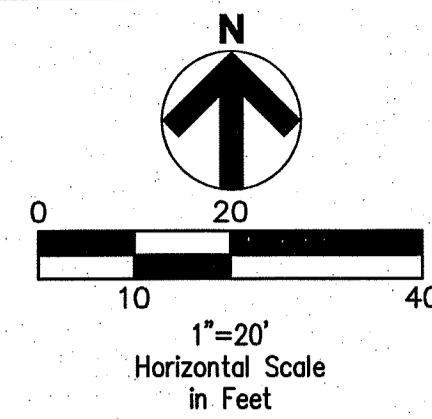

WATER MAIN FITTING SCHEDULE

ITEM	STATION	OFFSET
11.25° BEND	10+54.16	0
22.50° BEND	10+56.15	0
1" TAP	11+81.21	0
RIVER CROSSING CURB METER PIT	11+83.21	5.00' RT.
12" LINE VALVE	11+83.21	0
1" TAP	11+85.21	0
45° BEND	14+08.18	0
45° BEND	14+34.00	0


PLAN VIEW
SCALE: 1"=20'

NOTE:
ANY SERVICE LATERAL CROSSING WATER MAIN SHALL MAINTAIN 18" MINIMUM CLEARANCE.
ALL WATER MAIN PIPE JOINTS WITHIN AREAS OF FILL MUST BE RESTRAINED.

NOTE:
ALL OIL AND GAS WELL REMOVALS, PLUGGING/CAPPING, AND ABANDONMENTS SHALL BE IN ACCORDANCE WITH ALL ASSOCIATED REGULATIONS FOR SUCH REMOVALS, INCLUDING BUT NOT LIMITED TO, ODNR, LOCAL, STATE, AND FEDERAL.
EXISTING HIGH PRESSURE GAS MAIN SHALL BE LOCATED AND PROTECTED PRIOR TO AND THROUGHOUT CONSTRUCTION.

AS-BUILT LEGEND

	DESIGNED WATER VALVE
	DESIGNED HYDRANT
	ASBUILT ELECTRIC PULLBOX
	ASBUILT WATER VALVE
	ASBUILT HYDRANT
	STORM ASBUILT LATERAL TERMINATION
	SANITARY ASBUILT LATERAL TERMINATION
	WATER ASBUILT LATERAL TERMINATION

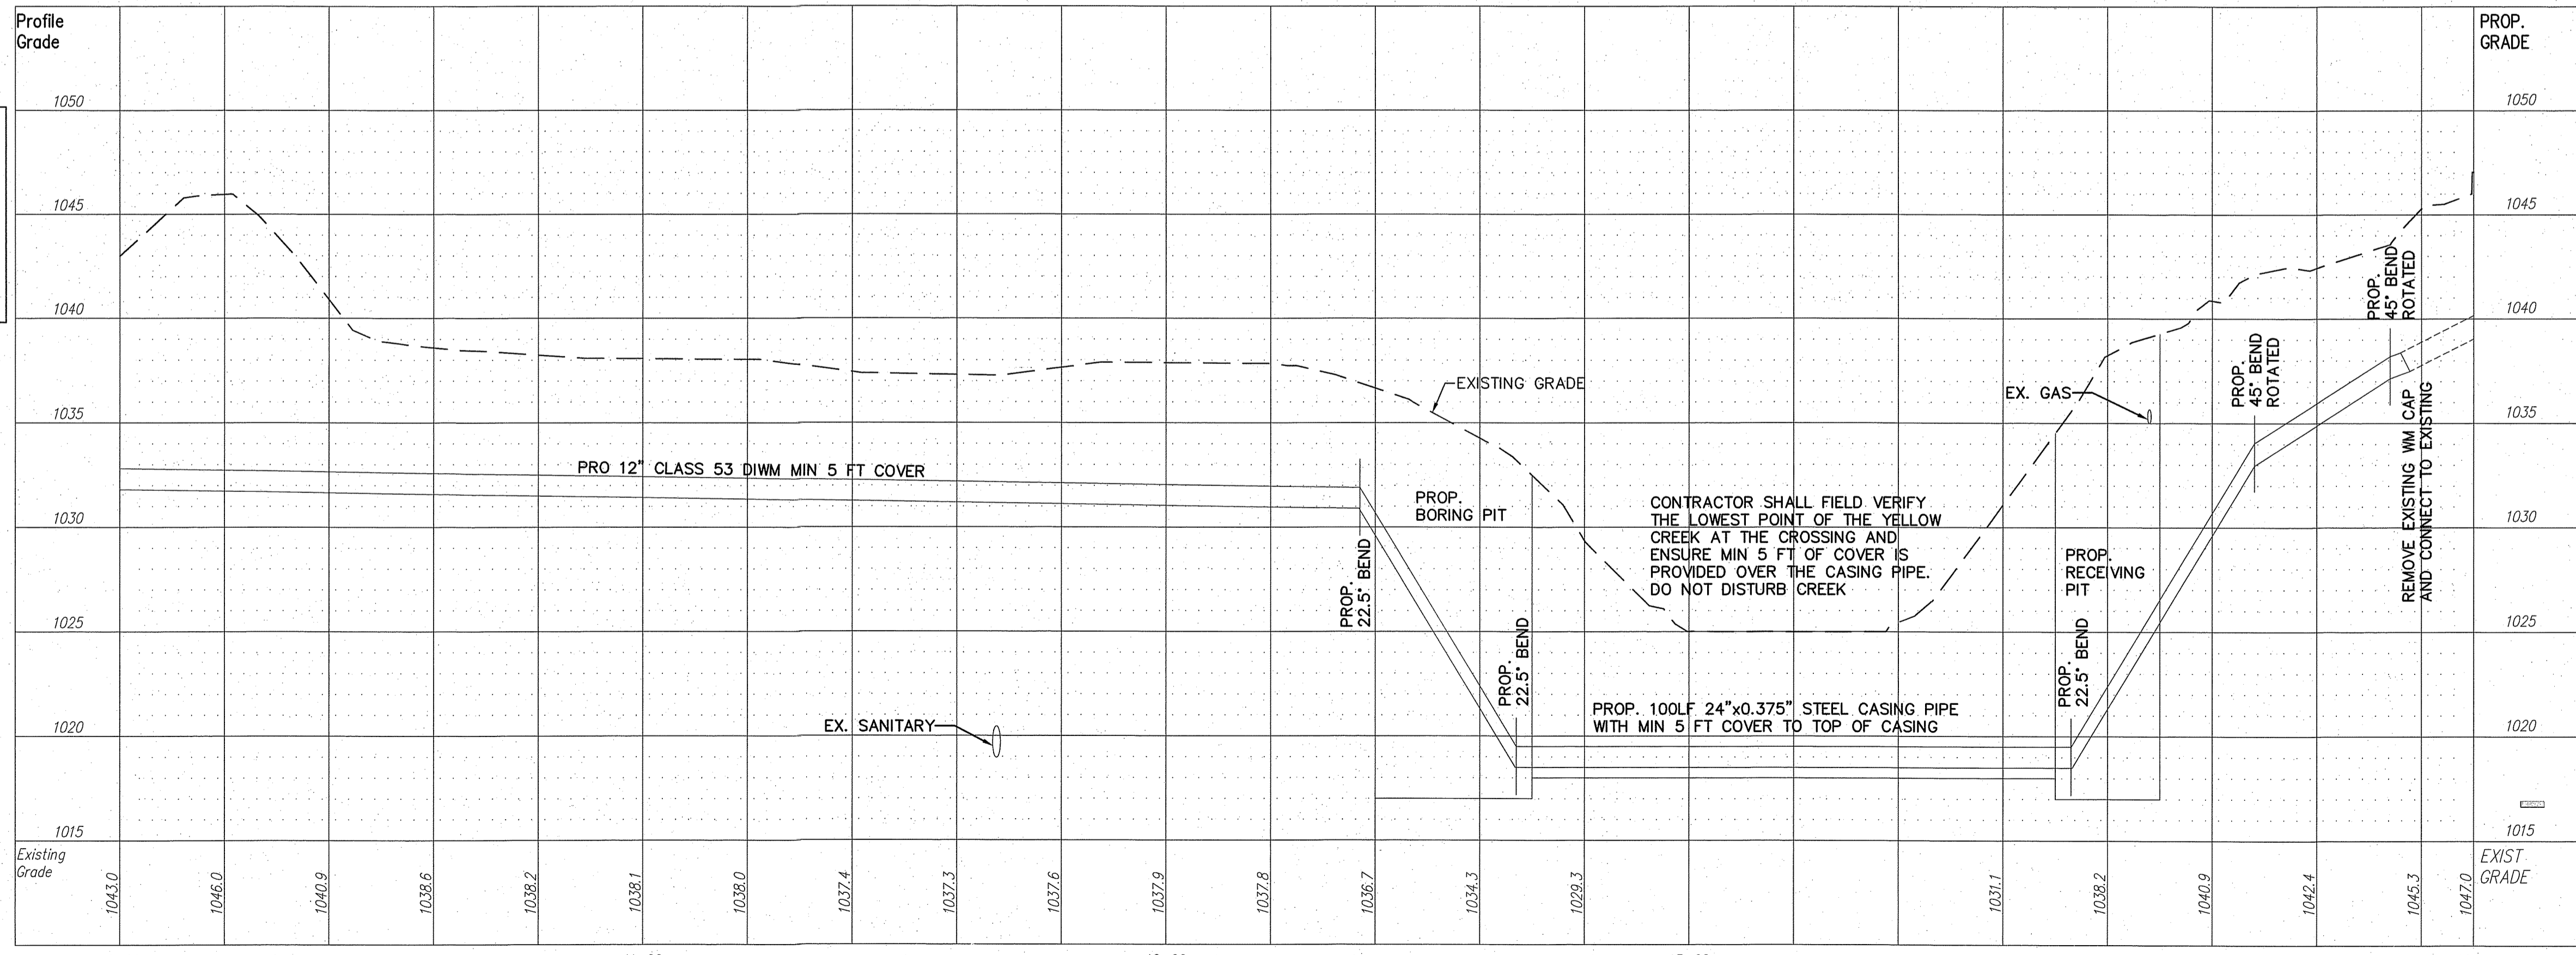

PROFILE VIEW
HORIZONTAL SCALE: 1"=20'
VERTICAL SCALE: 1"=5'

REV.	DATE	DESCRIPTION
1	12/9/14	BRIDGE PLAN REVISIONS

THE PRESERVE AT MILLER'S FARM
SE CORNER OF SR 18 AND MEDINA LINE RD
COPLEY, OHIO 44321

PLAN AND PROFILE
UTILITY

ISSUED FOR:

PERMIT	06-02-14
BID	06-02-14
CONSTRUCTION	09-16-14
AS-BUILT	02-26-15

PROJECT MANAGER MAL **DESIGNER** KB

JOB NO.
2013258.00

63/81